


GROUND FLOOR TV AND CCTV SYSTEM LAYOUT
SCALE 1:100

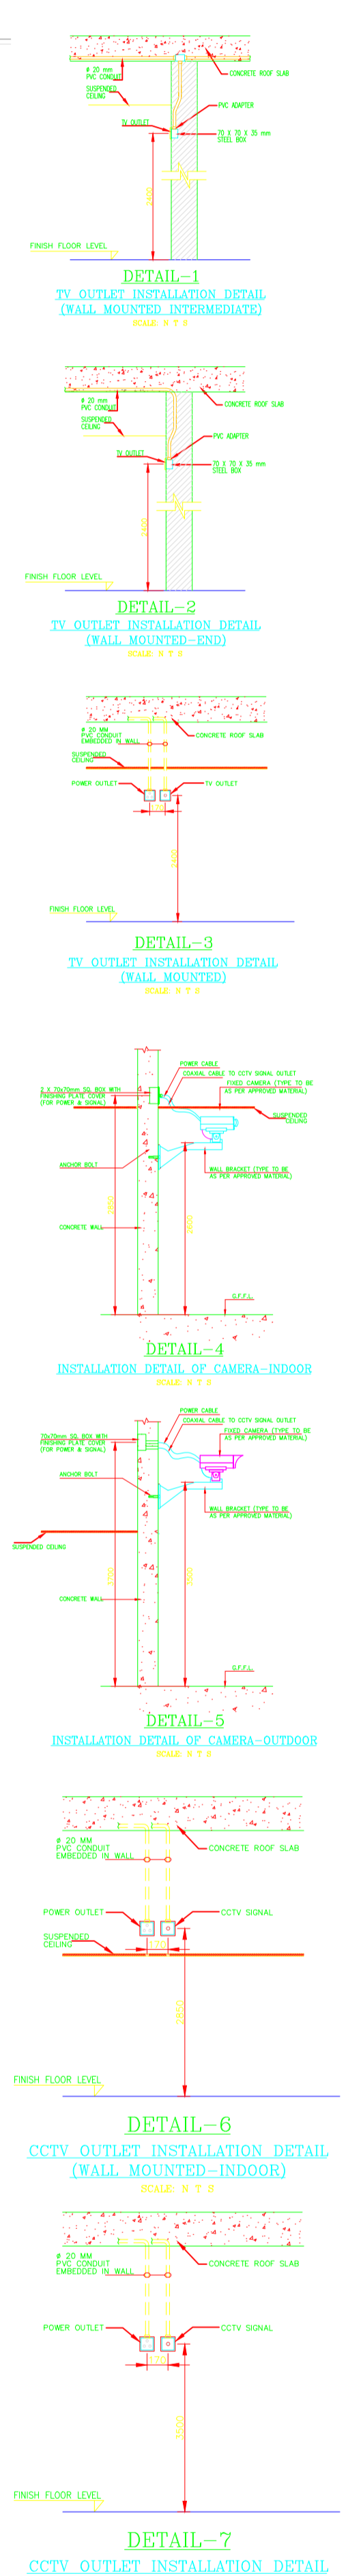

- NOTES:**
1. ALL DIMENSIONS ARE IN MILLIMETERS UNLESS OTHERWISE NOTED.
 2. PULL BOX WILL BE PROVIDED WHEREVER IT IS REQUIRED.
 3. MINIMUM SIZE OF PVC CONDUIT IS 25MM UNLESS AS PER MANUFACTURER'S RECOMMENDATION.
 4. THE WALL/CEILING MOUNTED TV ANTENNA OUTLET ARE TO BE PROVIDED AT DESIGN LEVEL OR AS PER THE REQUIRED LOCATION AND FINISHING.
 5. ALL MATERIALS TO BE USED SHALL BE NEW AND OF THE HIGHEST QUALITY FOR THE LOCATION AND FINISHING.
 6. THE SYSTEMS, CABLES, TV, POWER, ADDRESS, CENTRAL, CLOCK, TIME, ALARM, ETC. SYSTEMS ARE INDICATIVE ONLY. THE WORK HAS TO BE EXECUTED AS PER THE REQUIREMENT OF THE PRODUCT SUPPLIER.
 7. THE CONTRACTOR SHALL BE RESPONSIBLE FOR COORDINATING THE WORK AMONG THE VARIOUS TRADES AS NECESSARY TO AVOID CONFLICTS AND TO ENSURE THE INSTALLATION OF ALL WORK WITHIN THE AVAILABLE SPACE.
 8. ALL CCTV AND TV CONDUIT ARE EMBEDDED IN SLAB.
 9. ALL SPLITTER SHALL BE WALL MOUNTED ABOVE FALSE CEILING.
 10. FOR POWER OUTLET REFER TO POWER LAYOUT DRAWING.

- LEGEND:**
- CCTV INDOOR CAMERA (FIXED)
 - CCTV OUTDOOR CAMERA (FIXED)
 - SPLITTER
 - TELEVISION SOCKET OUTLET
 - PULL BOX
 - AMPLIFIER
 - TAP-OFF
 - FOR COAXIAL CABLE FOR TV EMBEDDED IN FLOOR SLAB
 - FOR COAXIAL CABLE FOR CCTV EMBEDDED IN FLOOR SLAB
 - POWER OUTLET

NO.	DATE	DESCRIPTION	SCALE	REVISED BY
0	12 NOV 2028	FOR APPROVAL	1:100	

R. P. Y. S. I. D. O. N. S.

CLIENT:
KINGDOM OF SAUDI ARABIA
MINISTRY OF HEALTH
GENERAL AND SPECIALIZED MEDICAL SERVICES

PROJECT NAME:
MEDICAL TOWER

CONSULTANT:
DAR AL-MAJID
CONSULTING ENGINEERS
GENERAL CONTRACTORS

GROUP CONTRACTOR:
AL-MANAL AL-ARABI
GROUP CONTRACTING
P.O. BOX: 18288 JEDDAH - SAUDI ARABIA
TEL: 011-222-1111
FAX: 011-222-1111

Sheet No.: MEDICAL TOWER
GROUND FLOOR
TV AND CCTV SYSTEM LAYOUT

NO.	DATE	DESCRIPTION	SCALE	REVISED BY
0	11 NOV 2028	ISSUED FOR APPROVAL	1:100	

PROJECT NO.: MT-EL-402

DISCIPLINE: ELECTRICAL

DESIGNER: SED-EL-MT-027-01